

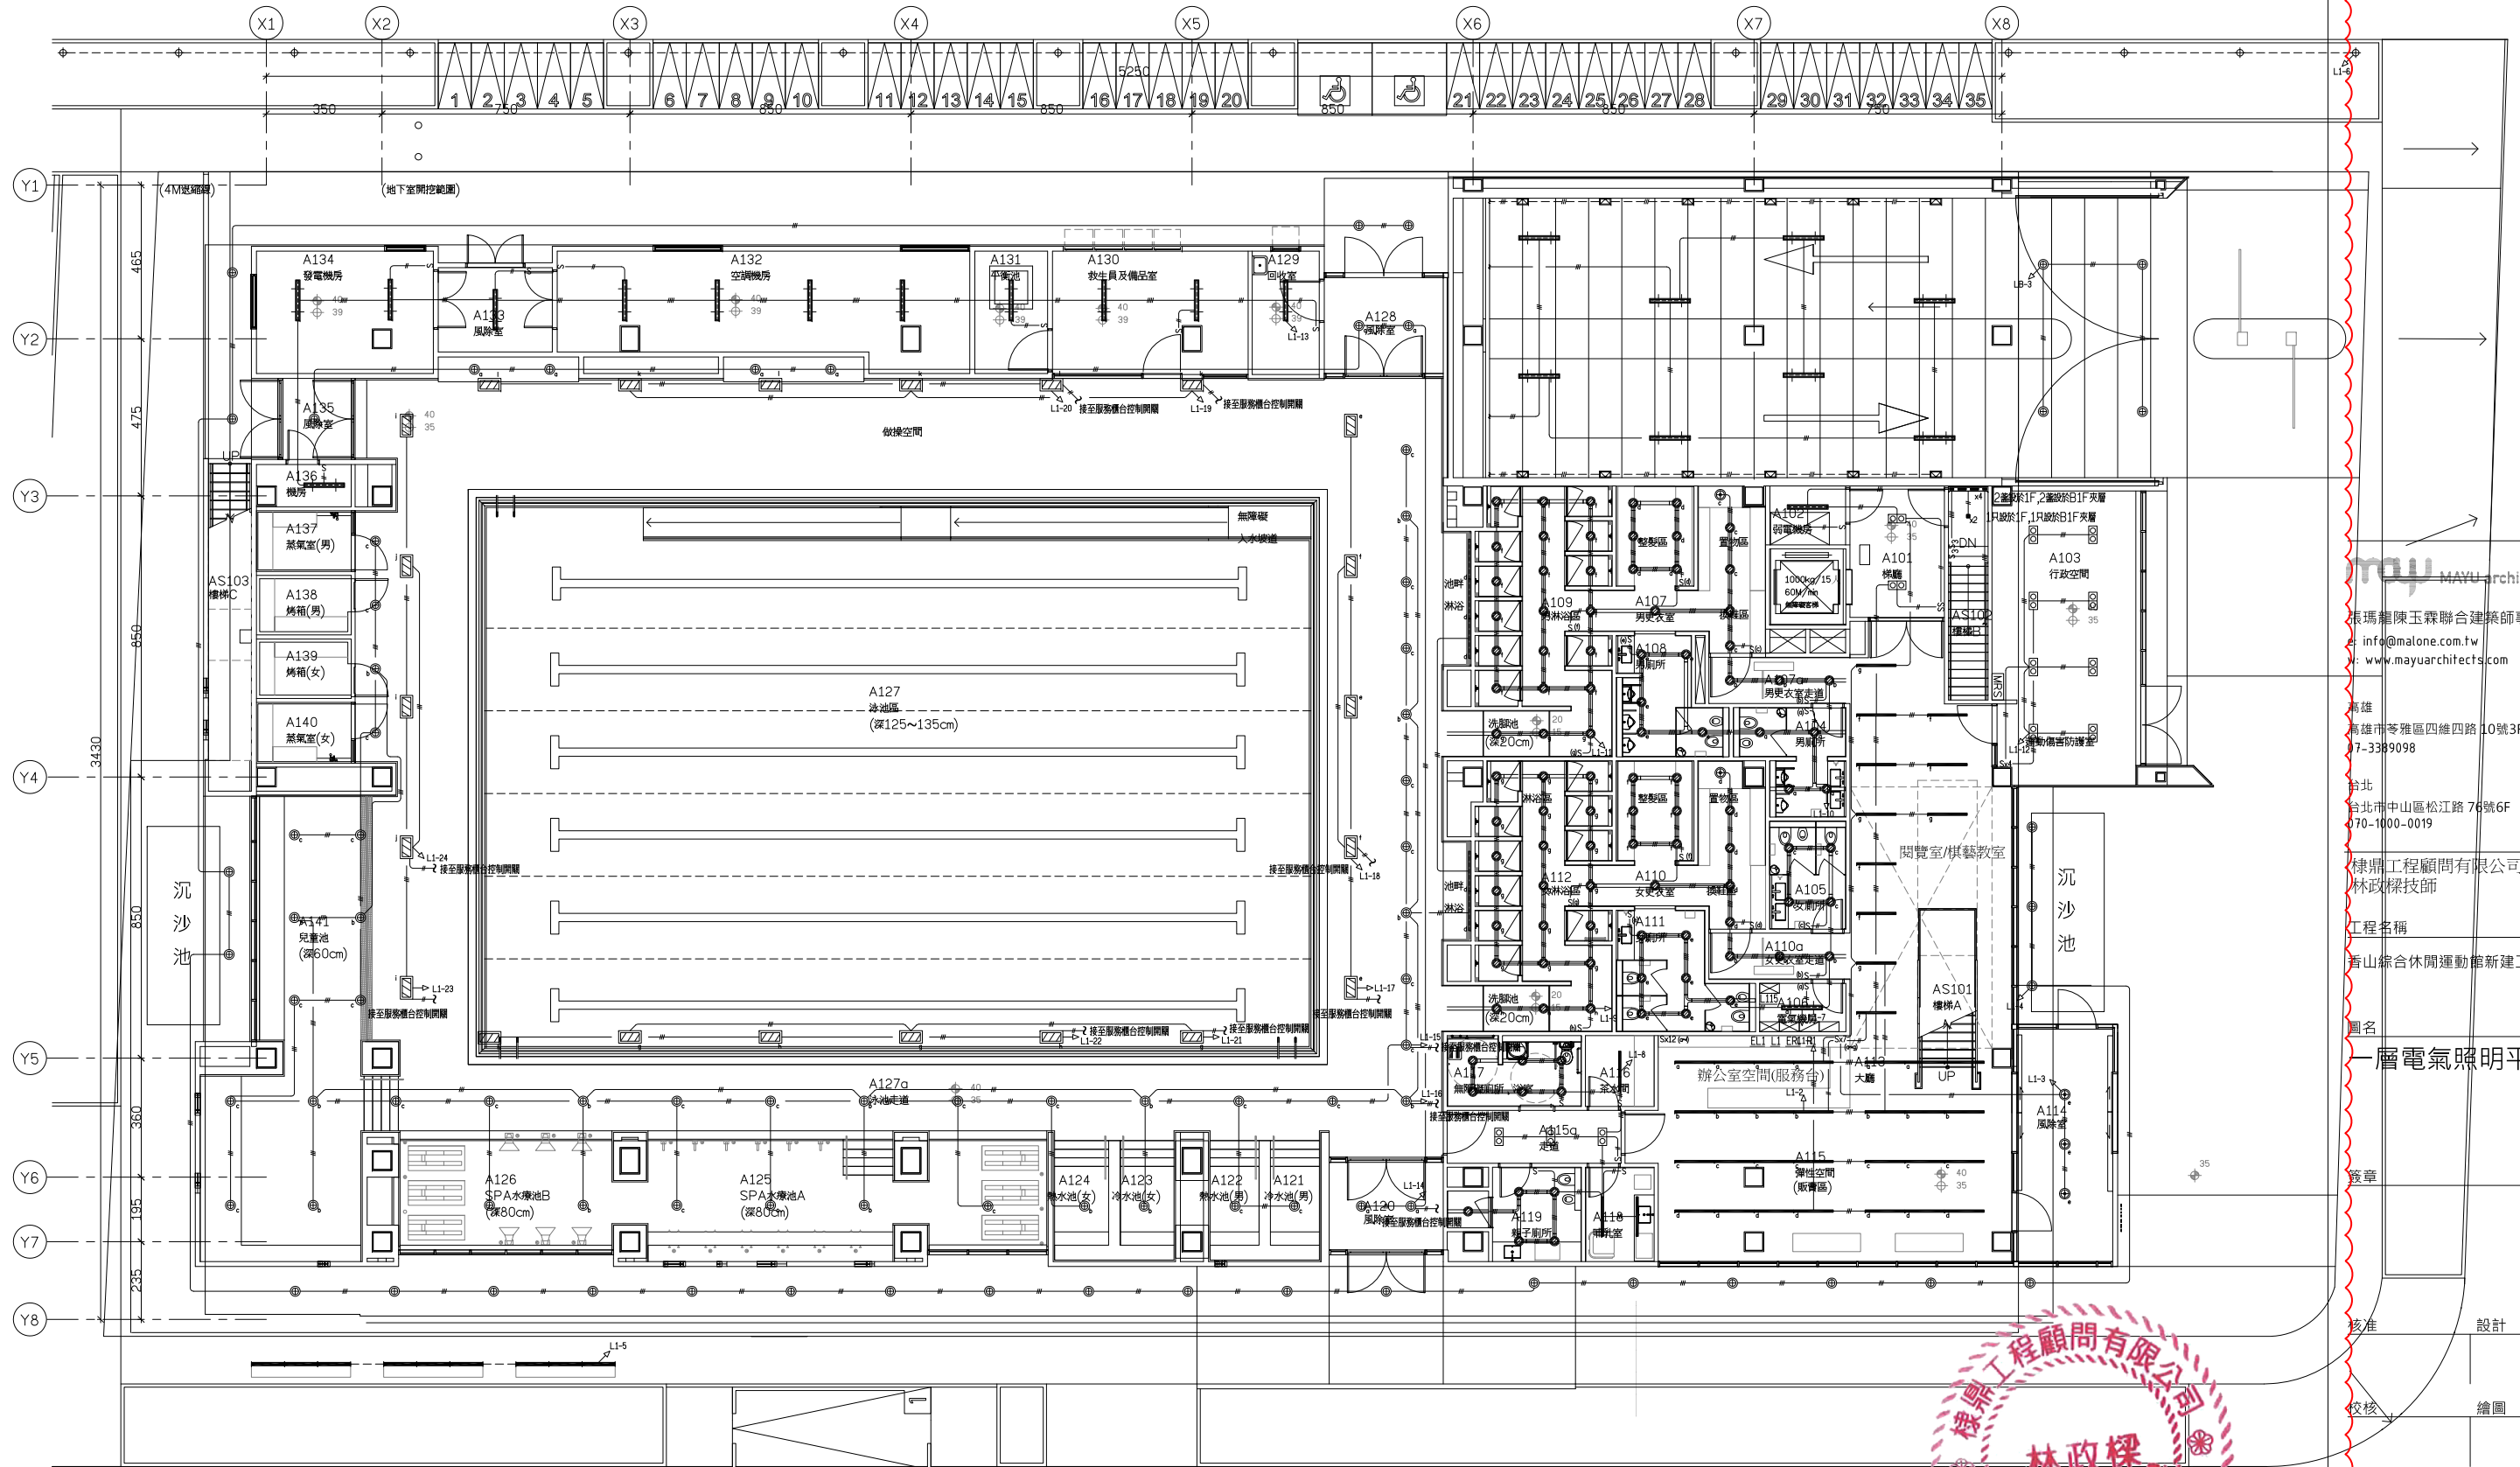


圖 例	數量	圖 例	數量	圖 例	數量	圖 例	數量
	1		13		4		13
	21		5		22	$S S_3$	55
	5		86		12		2
	42		101		9		

許政祥 層電氣照明平面圖
 SCALE: A1: 1/10, A3: 1/2



日期			
110/03/29			
張號		圖號	