
 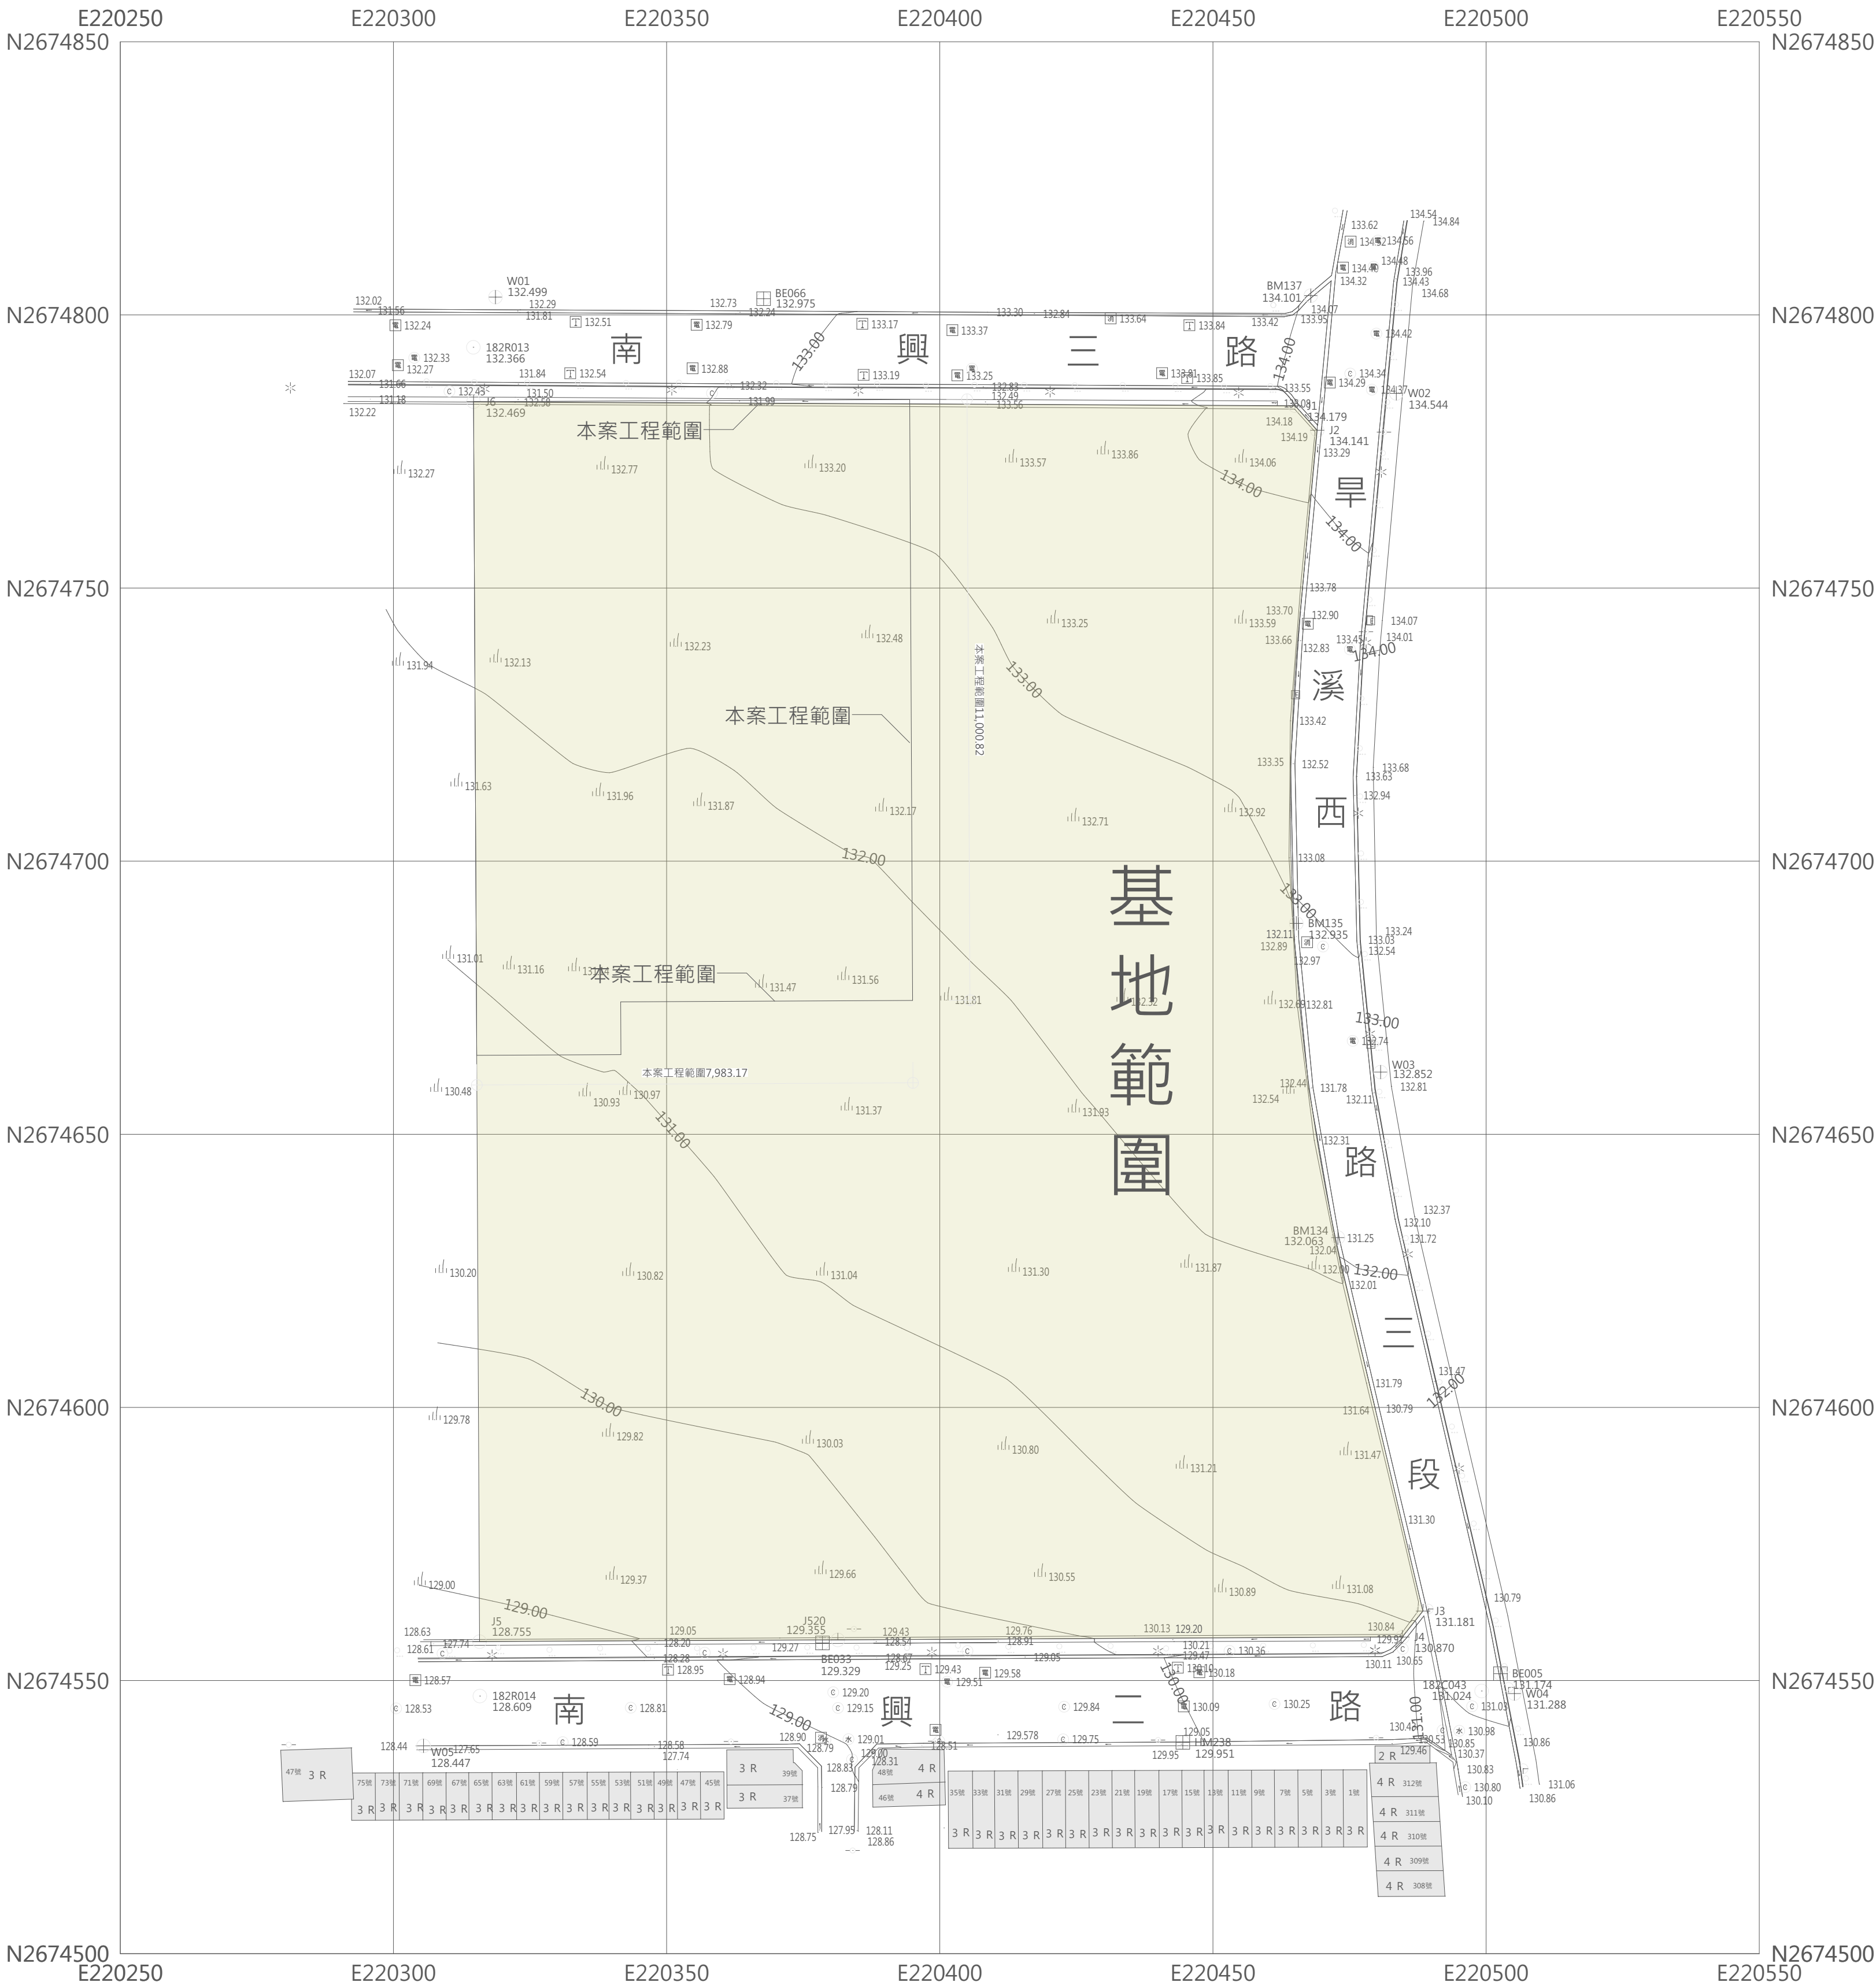
 
 
 


臺中市北屯區南興段236地號附近 現況成果圖



點 名	縱 坐 標 (N)	橫 坐 標 (E)	高 程	點位類型
BE005	2674551.253	220502.625	131.132	現有圖根點
BE033	2674556.882	220378.524	129.354	現有圖根點
BE066	2674802.967	220367.754	132.975	現有圖根點
BM134	2674631.084	220472.871	132.051	新設工區控制點
BM135	2674688.617	220465.264	132.945	新設工區控制點
BM137	2674803.523	220467.908	134.113	新設工區控制點
W01	2674803.259	220318.669	132.505	新設工區控制點
W02	2674785.633	220483.565	134.559	新設工區控制點
W03	2674661.385	220480.690	132.819	新設工區控制點
W04	2674547.619	220505.170	131.293	新設工區控制點
W05	2674538.045	220305.506	128.469	新設工區控制點

圖例表		圖例表		圖例表	
圖示	地物名稱	圖示	地物名稱	圖示	地物名稱
	鐵絲網		闊葉林		河川流向
	暗溝		路燈		方型電力人孔
	永久房屋		圓型污水人孔		方型電信人孔
	硬路面道路		都市計畫格		圓型電力人孔
	結構線		交通標誌		方型消防栓
	人行道		變壓箱座		草地
	獨立標高點		混凝土屋		工區控制點
	溝底高程點		電力桿		圖根點
	等高線		圓型制水閥		界樁

說明

[illegible]

工程名稱
臺中市北屯區南興國民小學
第一期校舍新建工程

姜樂靜建築師事務所
臺中市西屯區臺灣大道二段902號3樓
TEL：04-23152015
FAX：04-23152017
EMAIL：leching@ms3.hinet.net

圖名
現況測量圖(全區)

核准	比例 $A1 : 1/$ $A3 : 1/$
設計	日期
繪圖	核對
圖號 A1-04	張號 10

業務號